

# ICAL POWER PLAN

SCALE: 1/8" = 1'-0"


## FIRE ALARM ONE LINE DIAGRAM

NO SCALE  
FIRE ALARM SYSTEM SUBJECT TO APPROVAL BY TOWN OF CLARKSTOWN FIRE INSPECTOR

FIRE ALARM LEGEND	
KEY	DESCRIPTION
F.A.C.P.	FIRE ALARM CONTROL PANEL WITH BATTERY BACKUP
ANNUC	ANNUNCIATOR PANEL
F	MANUAL FIRE ALARM PULL STATION
H	FIRE ALARM HORN
KL	FIRE ALARM STROBE LIGHT
KLH	FIRE ALARM HORN AND STROBE

# USED FLOORING LAYOUT PLAN

SCALE: 1/8" = 1'-0"

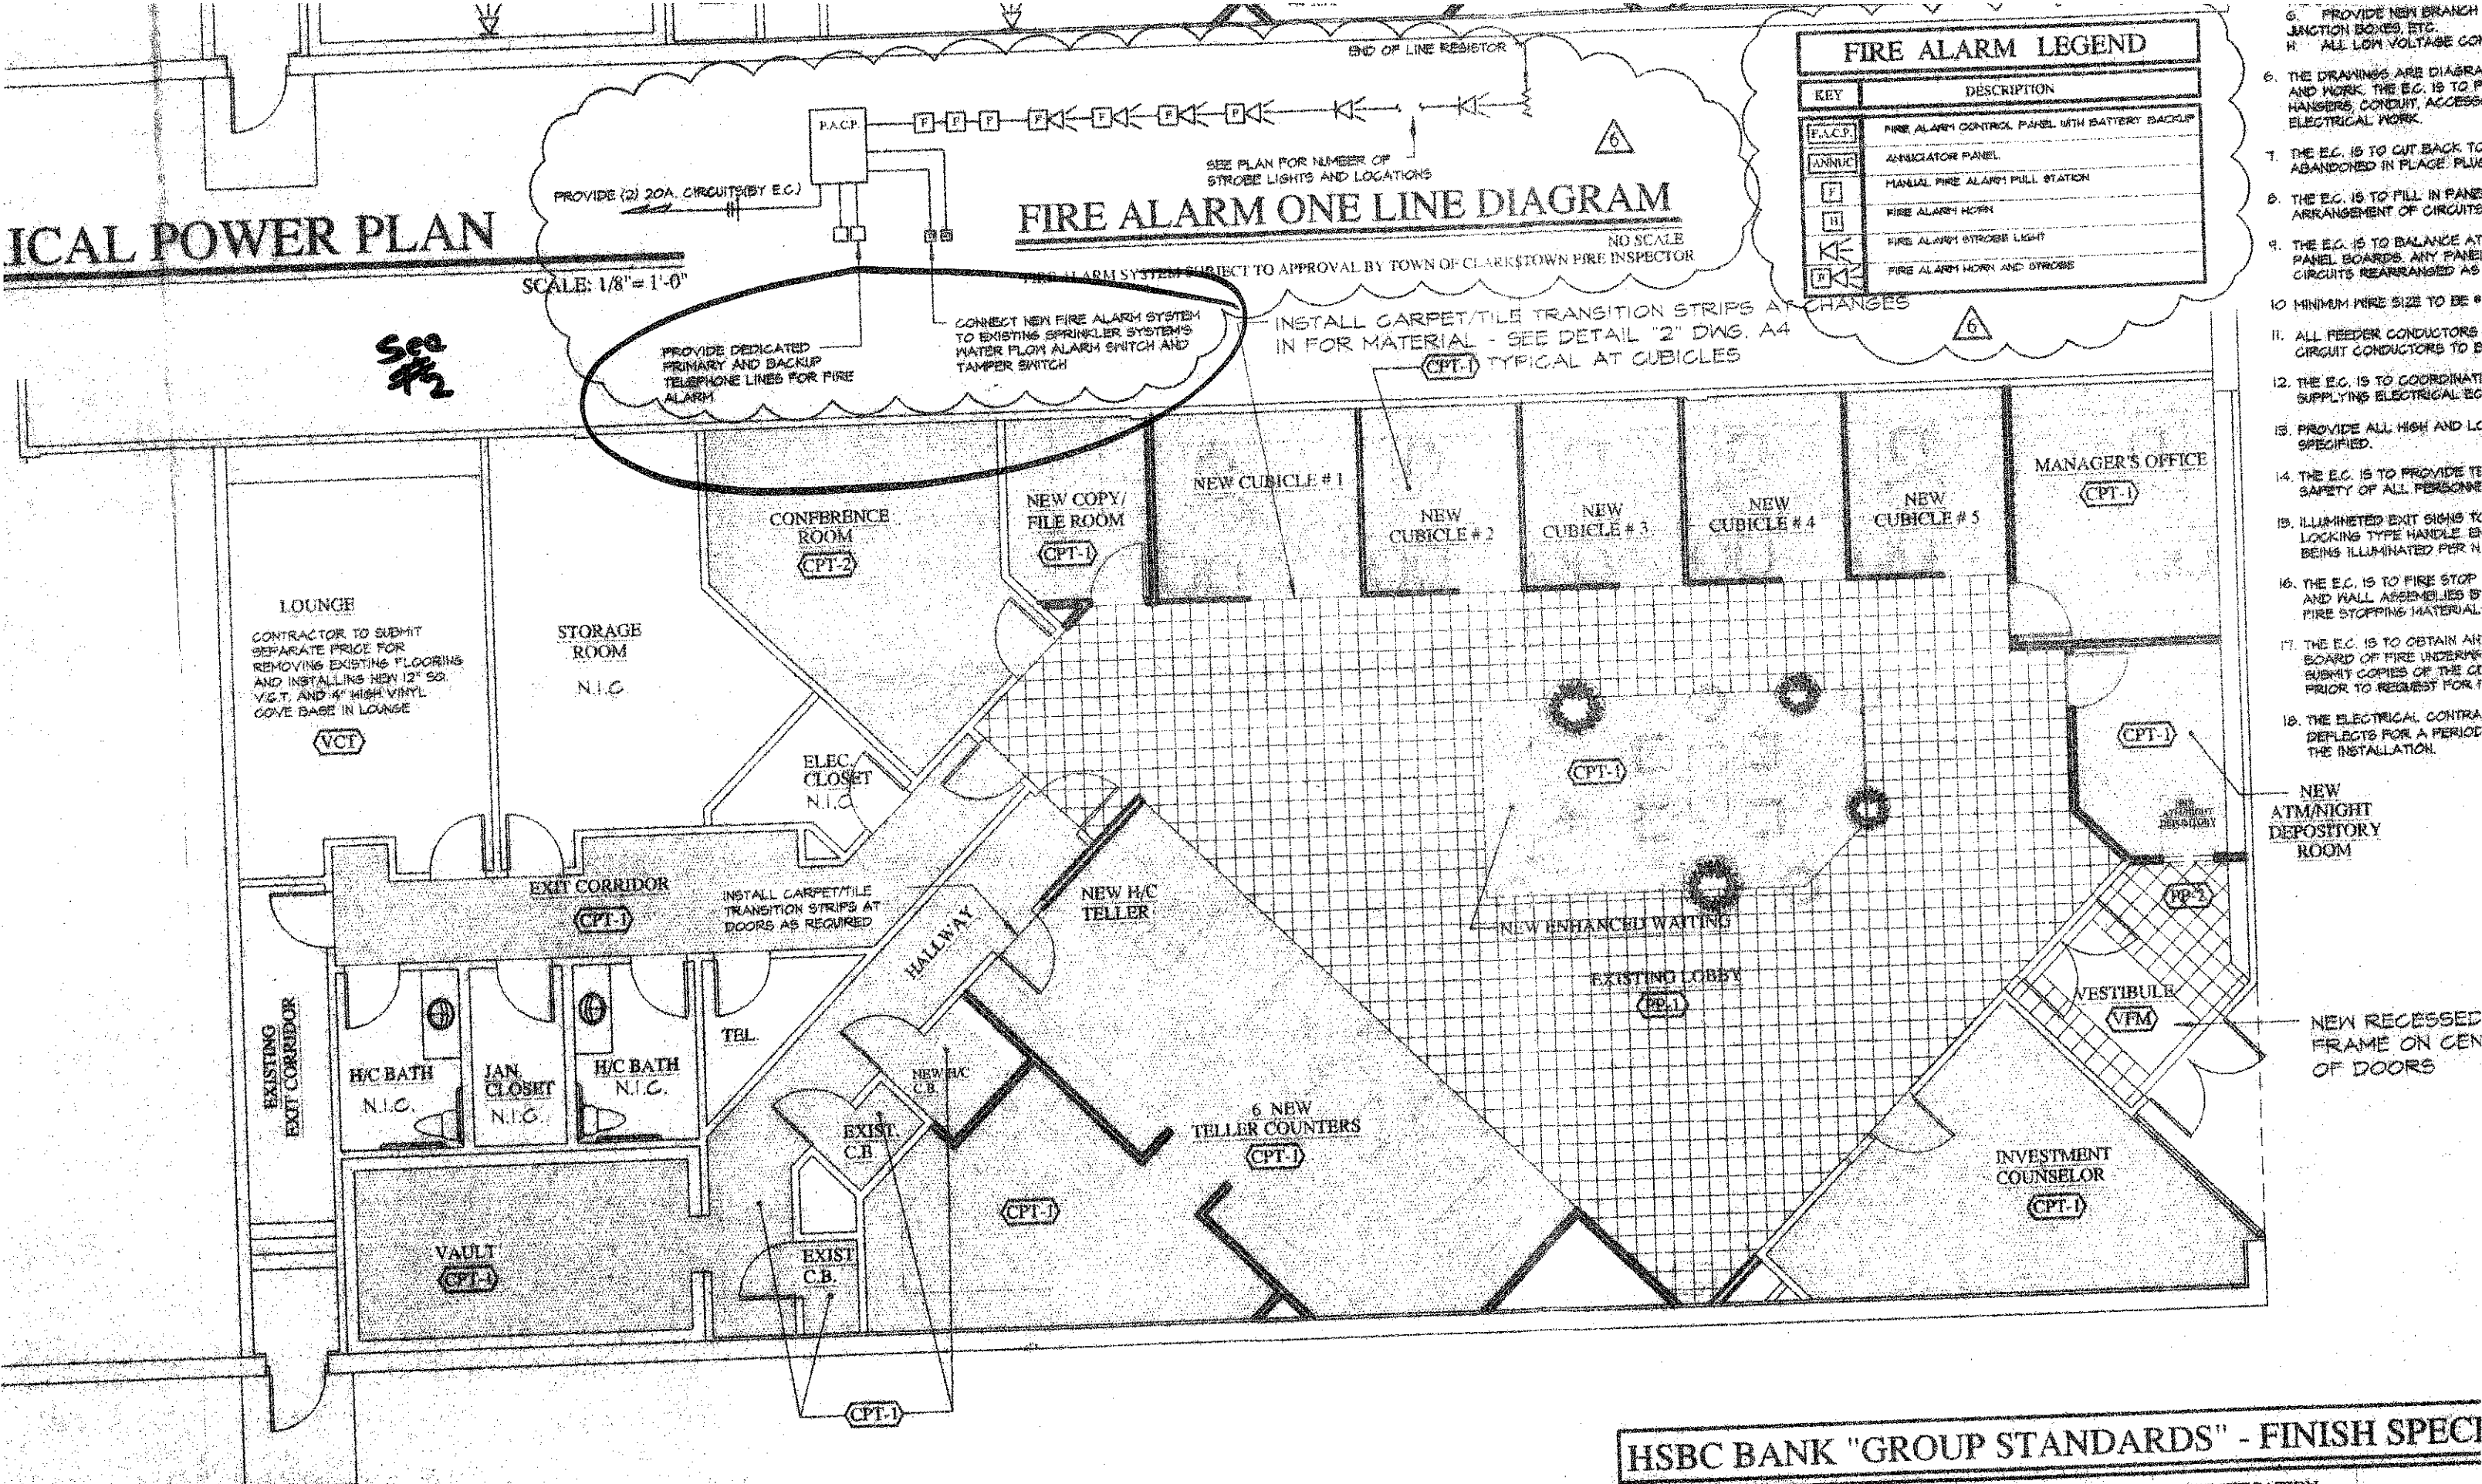

6. PROVIDE NEW BRANCH JUNCTION BOXES, ETC.
- H. ALL LOW VOLTAGE CO
6. THE DRAWINGS ARE DIAGRA AND WORK. THE E.C. IS TO P HANGERS, CONDUIT, ACCESS ELECTRICAL WORK.
7. THE E.C. IS TO CUT BACK TO ABANDONED IN PLACE. PLUS
8. THE E.C. IS TO FILL IN PANEL ARRANGEMENT OF CIRCUITS
9. THE E.C. IS TO BALANCE AT PANEL BOARDS. ANY PANEL CIRCUITS REARRANGED AS
10. MINIMUM WIRE SIZE TO BE 6
11. ALL FEEDER CONDUCTORS CIRCUIT CONDUCTORS TO B
12. THE E.C. IS TO COORDINATE SUPPLYING ELECTRICAL E.C
13. PROVIDE ALL HIGH AND LC SPECIFIED.
14. THE E.C. IS TO PROVIDE TE SAFETY OF ALL PERSONE
15. ILLUMINATED EXIT SIGNS TO LOCKING TYPE HANDLE ED BEING ILLUMINATED PER N
16. THE E.C. IS TO FIRE STOP AND WALL ASSEMBLIES BY FIRE STOPPING MATERIAL.
17. THE E.C. IS TO OBTAIN AN BOARD OF FIRE UNDERWRITERS SUBMIT COPIES OF THE CE PRIOR TO REQUEST FOR T
18. THE ELECTRICAL CONTRA DEFLECTS FOR A PERIOD THE INSTALLATION.

## HSBC BANK "GROUP STANDARDS" - FINISH SPECI

ITEM AND LOCATION	MANUFACTURER	SPECIFICATION	
CARPET - PLATFORM AREA & TELLER LINE	MILLIKEN CARPET	DR-2745/99 "GREY SPECKLED"	ATTN: KEVIN MCK MILLIKEN CARPET 129 WEST AVENUE EAST ROCHESTER (716) 249-9494
CARPET - CONF. RM./WAITING RM. & CUSTOMER SERVICE AREA	MILLIKEN CARPET	DR-3287/99 "RED SPECKLED"	
	CARSAR	12" X 12" "CRYSTAL PLATINO"	ATTN: DONALD J CREATIVE MATR